


RECEIVED
SEP 10 2021
BLAINE COUNTY
LAND USE & BUILDING SERVICES

| Symbol | Label | Image | QTY | Manufacturer | Catalog Number | Description | Label | Number | Photometric | Lumens per luminaire | Lumens Multiple | LLF | Wallplug | Efficiency | Mounting | Pole Pat | Notes |
|--------|----------|-------|-----|-------------------|------------------------------|--|-------|--------|---------------------------------|----------------------|-----------------|-----|----------|------------|-------------------------------------|----------|-------|
| A | | | 6 | Lithonia Lighting | KAD_LED_BSC_700_80K_84_MVOLT | KAD_LED_80_LED_700mA_84VOLT_DRIVER_8000K_TYPE_4_OPTICS_POLE_MOUNTED | | 1 | KAD_LED_BSC_700_80K_84_MVOLT_84 | 18001 | 1 | 1 | 137 | 100% | TYPE IV MEDIUM BUD RATING 85-125 GS | | |
| B | NOT USED | | | | | | | | | | | | | | | | |
| C | | | 10 | Lithonia Lighting | KAD_LED_BSC_700_80K_84_MVOLT | KAD_LED_80_LED_700mA_84VOLT_DRIVER_8000K_TYPE_4_OPTICS_BUILDING_WALL_MOUNTED | | 1 | KAD_LED_BSC_700_80K_84_MVOLT_84 | 18001 | 1 | 1 | 137 | 100% | TYPE IV MEDIUM BUD RATING 85-125 GS | | |

| Description | Symbol | Avg | Min | Max | Mounting | Height |
|-------------|--------|------|------|------|----------|--------|
| TYPE A | A | 6.7m | 6.0m | 6.8m | typ | typ |

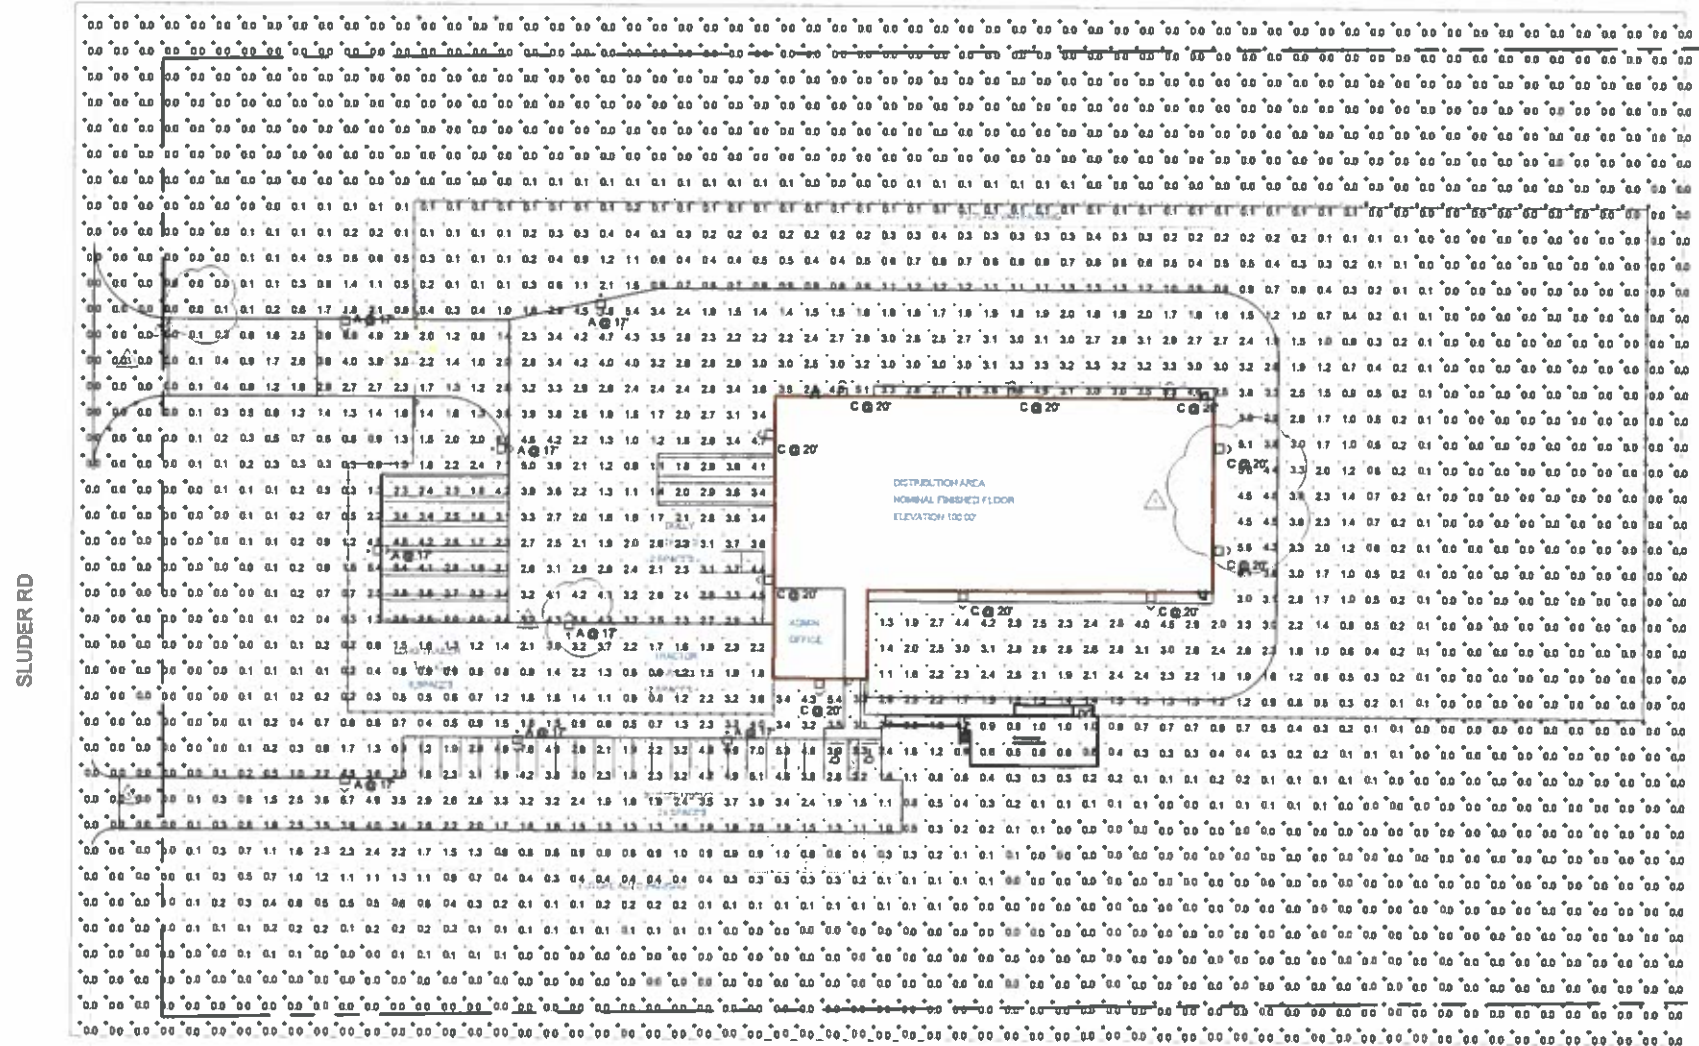

N
1 SITE LIGHTING PLAN
SLI.1 SCALE 1" = 40'

A-8
EXHIBIT

SITE DEVELOPMENT PLAN
180 GLENDALE RD
BELLEVUE, IDAHO

| NO. | REVISION | DATE |
|-----|--|----------|
| 1 | SITE LIGHTING PLAN - REVISED PER COMMENTS | 9/9/2021 |
| 2 | ALL PAVING FINISHED TO 1" RITE #17 ADDED - FINISHED PER COMMENTS | 9/9/2021 |
| 3 | FINISHED FLOOR FOR LIGHT SPILLAGE AT DORTY ROAD ENTRIES | 9/9/2021 |

SHEET TITLE:
SITE LIGHTING PLAN

JOB NUMBER: 21003
DESIGNED BY: TC
DRAWN BY: TC
CHECKED BY: TC
DATE: 08/11/2021
SHEET NO:

SLI.1